



HOW THE GASIFIER WORKS

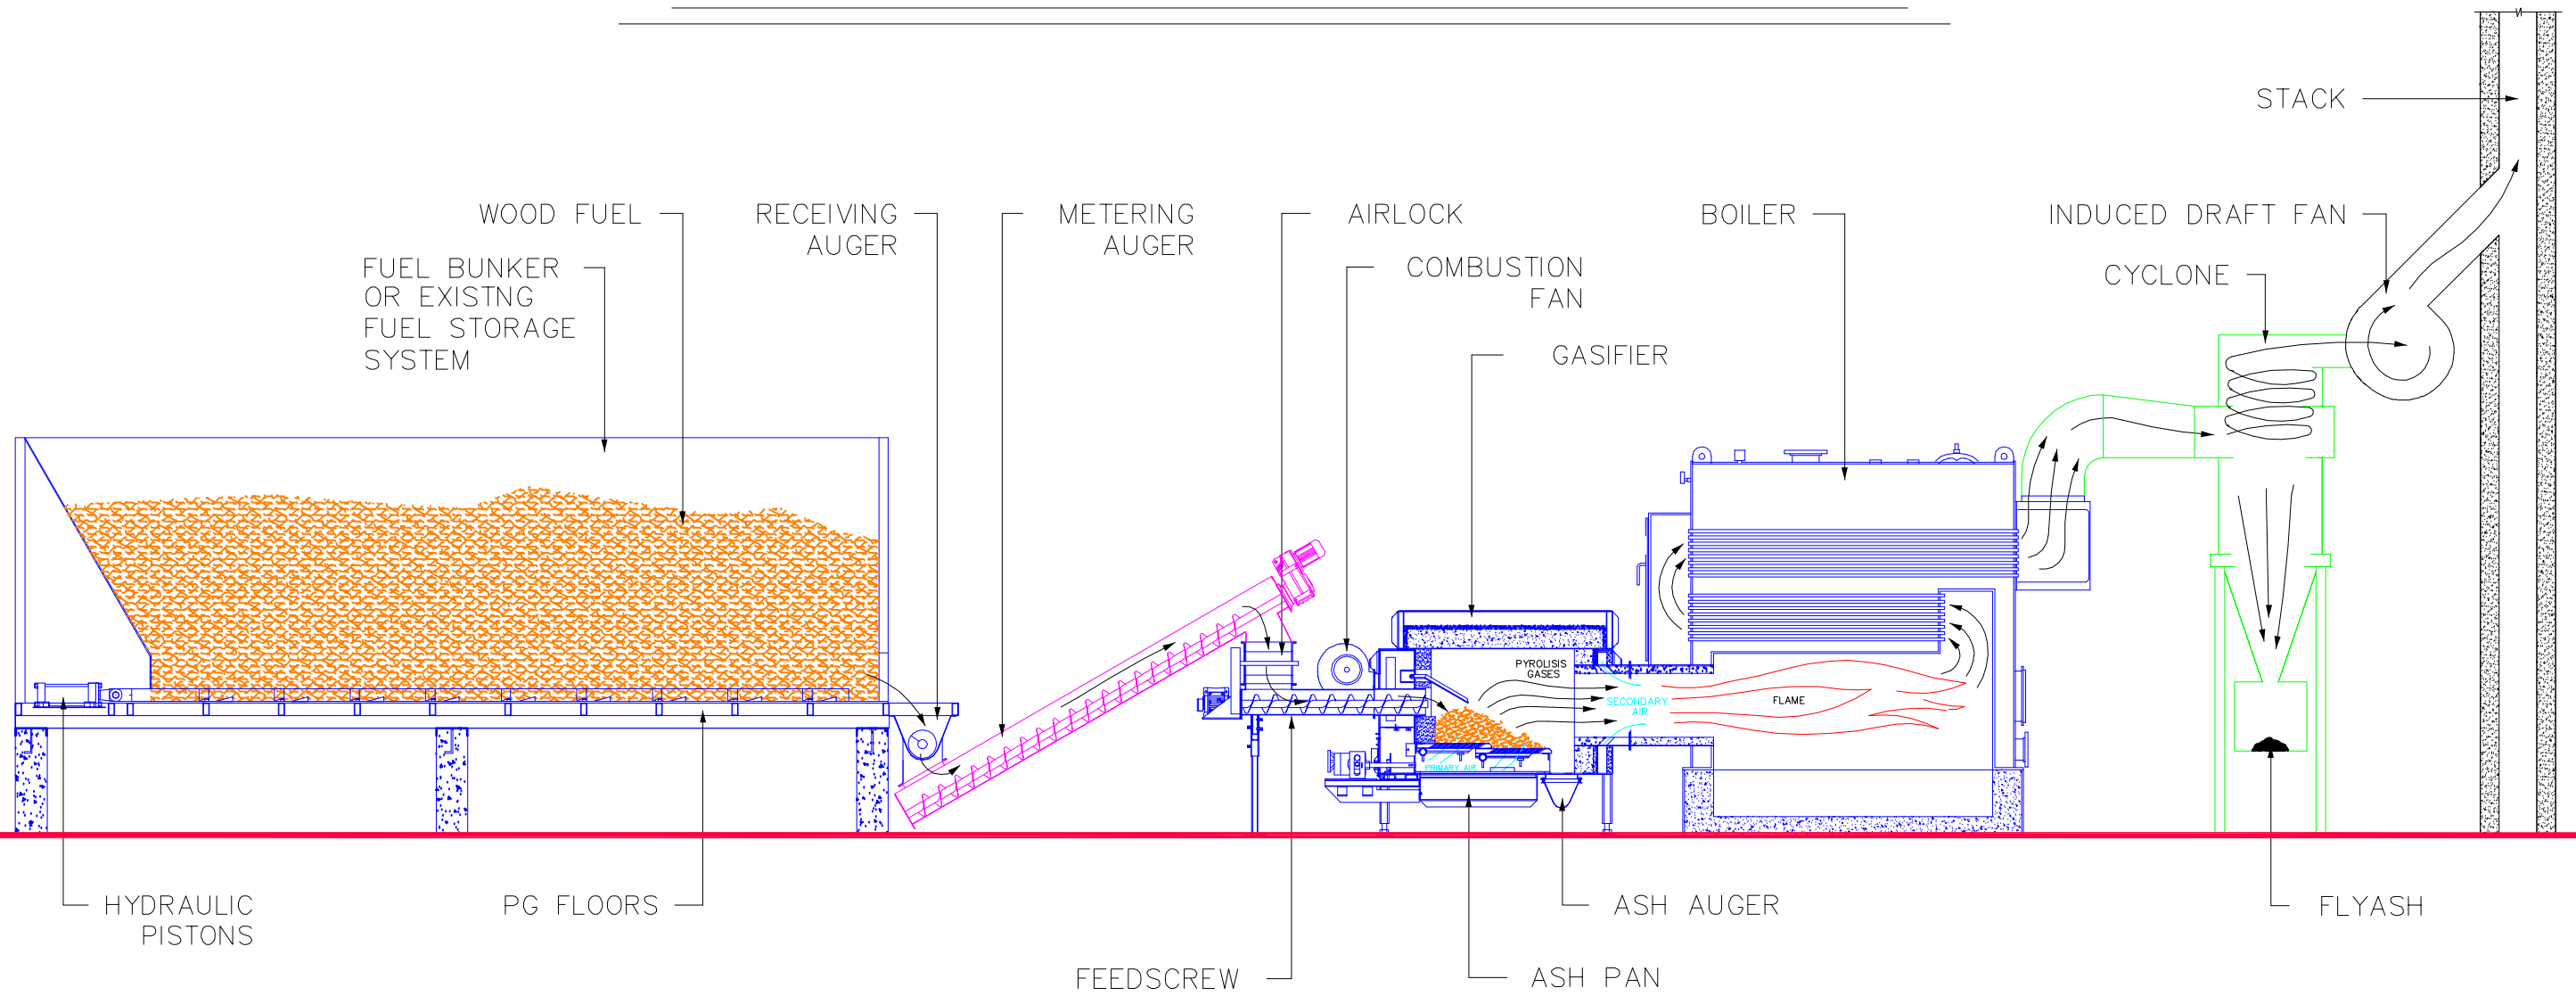

**PROCESS FLOW DIAGRAM
ACTUAL LAYOUT IS TAILORED TO YOUR NEEDS**

ANY UNAUTHORIZED USE OR DISCLOSURE OF ANY CONFIDENTIAL OR PROPRIETY INFORMATION DISCOVERED FROM THIS DRAWING WITHOUT PRIOR WRITTEN CONSENT FROM CHIPTEC CORP. MAY BE SUBJECT TO A RESTRAINING ORDER AND TRIPLE DAMAGES.

 CHIPTEC
WOOD ENERGY SYSTEMS



48 Helen Avenue
South Burlington
Vermont 05403
Tel: 802-658-0956
Fax: 802-660-8904
Shop: 802-453-4919

PROJECT NAME:

DRAWING TITLE

SAMPLE
DRAWING

SIZE:

B

SHEET NO.:

1 OF 1

NOTE: DO NOT SCALE!!! THIS DRAWING MAY HAVE BEEN REPRODUCED AT A SMALLER SIZE THAN THE ORIGINAL AND IS NOT NECESSARILY TO SCALE

DATE: 10-20-98 SCALE: NONE

DRAWN BY: KP CHECKED BY: JT

FILE: CX-4_FUNCTION.DWG